






NOTES

REFER TO MECHANICAL AND ELECTRICAL DWGS. FOR
ADDITIONAL DETAILS


SYMBOL	DESCRIPTION
	SURFACE / PENDANT MOUNTED INDUSTRIAL FLUORESCENT LIGHT FIXTURE
	SURFACE MOUNTED INDUSTRIAL FLUORESCENT LIGHT FIXTURE W/ BATTERY BACKUP
	RECESSED FLUORESCENT LIGHT FIXTURE W/ PLASTIC LENS
	RECESSED FLUORESCENT LIGHT FIXTURE W/ PLASTIC LENS AND BATTERY BACKUP
	4X4 RECESSED LIGHT FIXTURE
	A/C SUPPLY DIFFUSER
	EXHAUST GRILLE
	EXIT LIGHT
	SURFACE FLUORESCENT DOWN LIGHT
	STUCCO CEILING
	GYP. BD. CEILING
	PLASTER CEILING

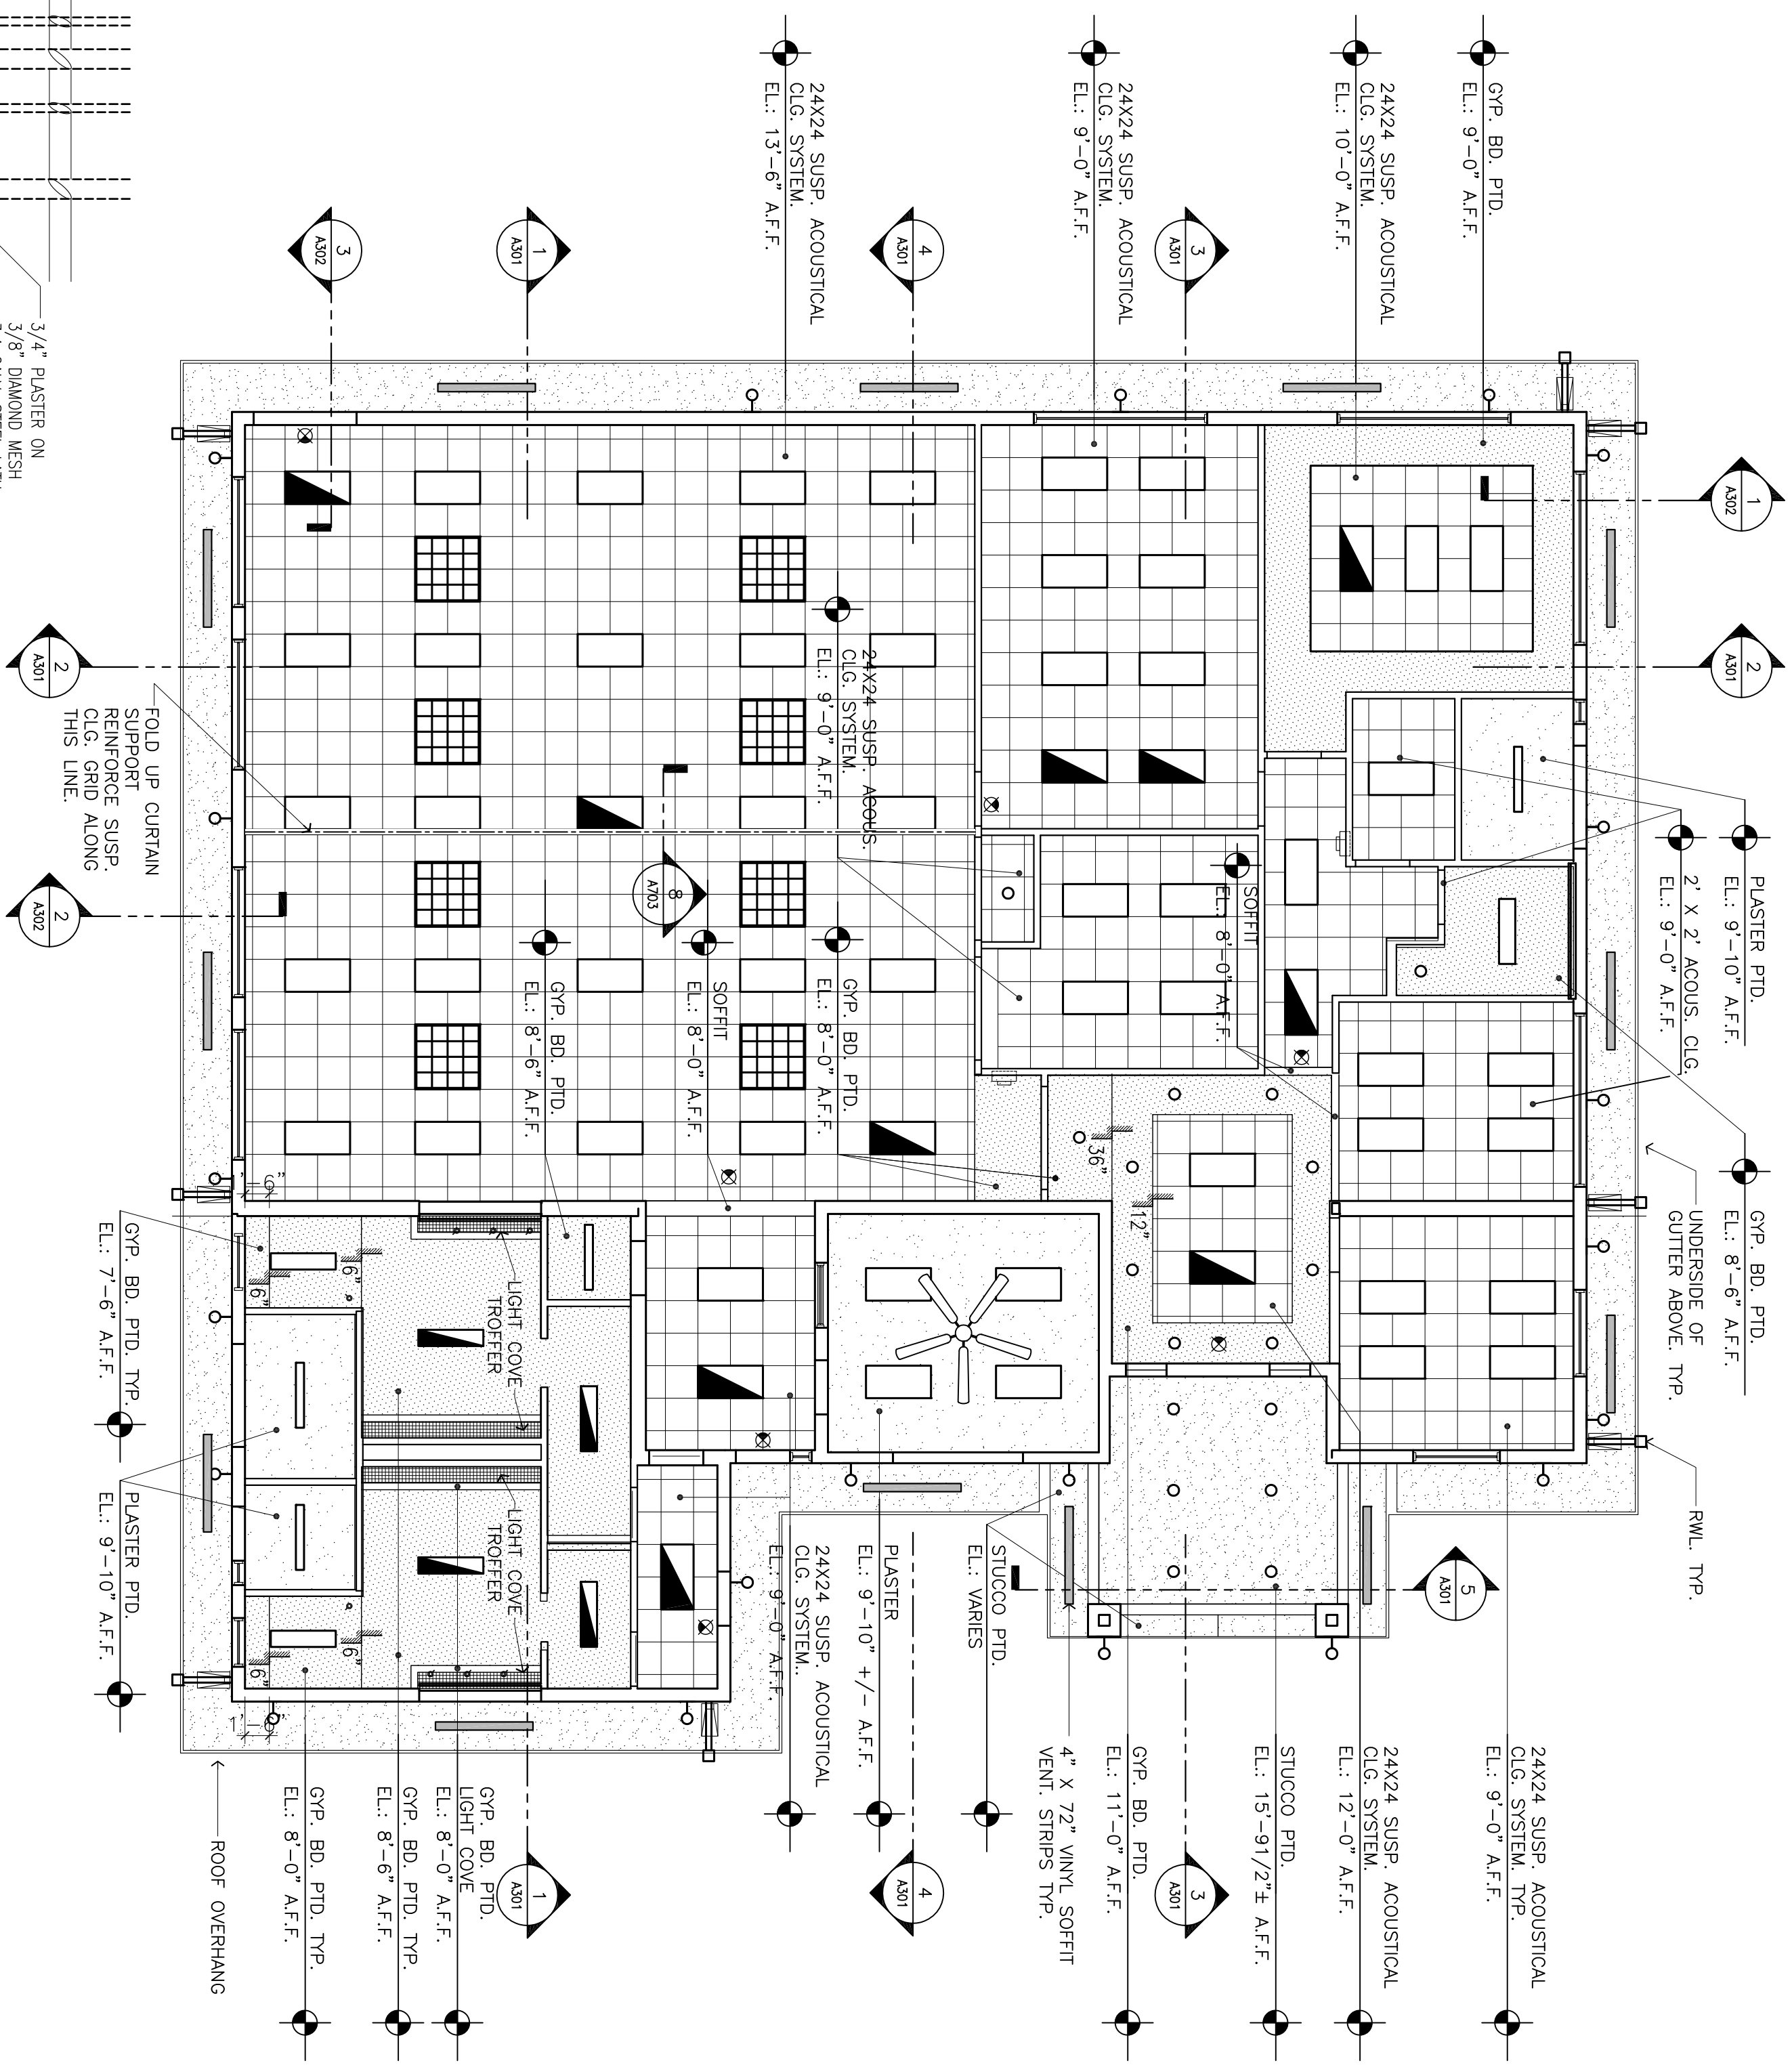


1 REFLECTED CEILING PLAN
SCALE: 1/8" = 1'-0"

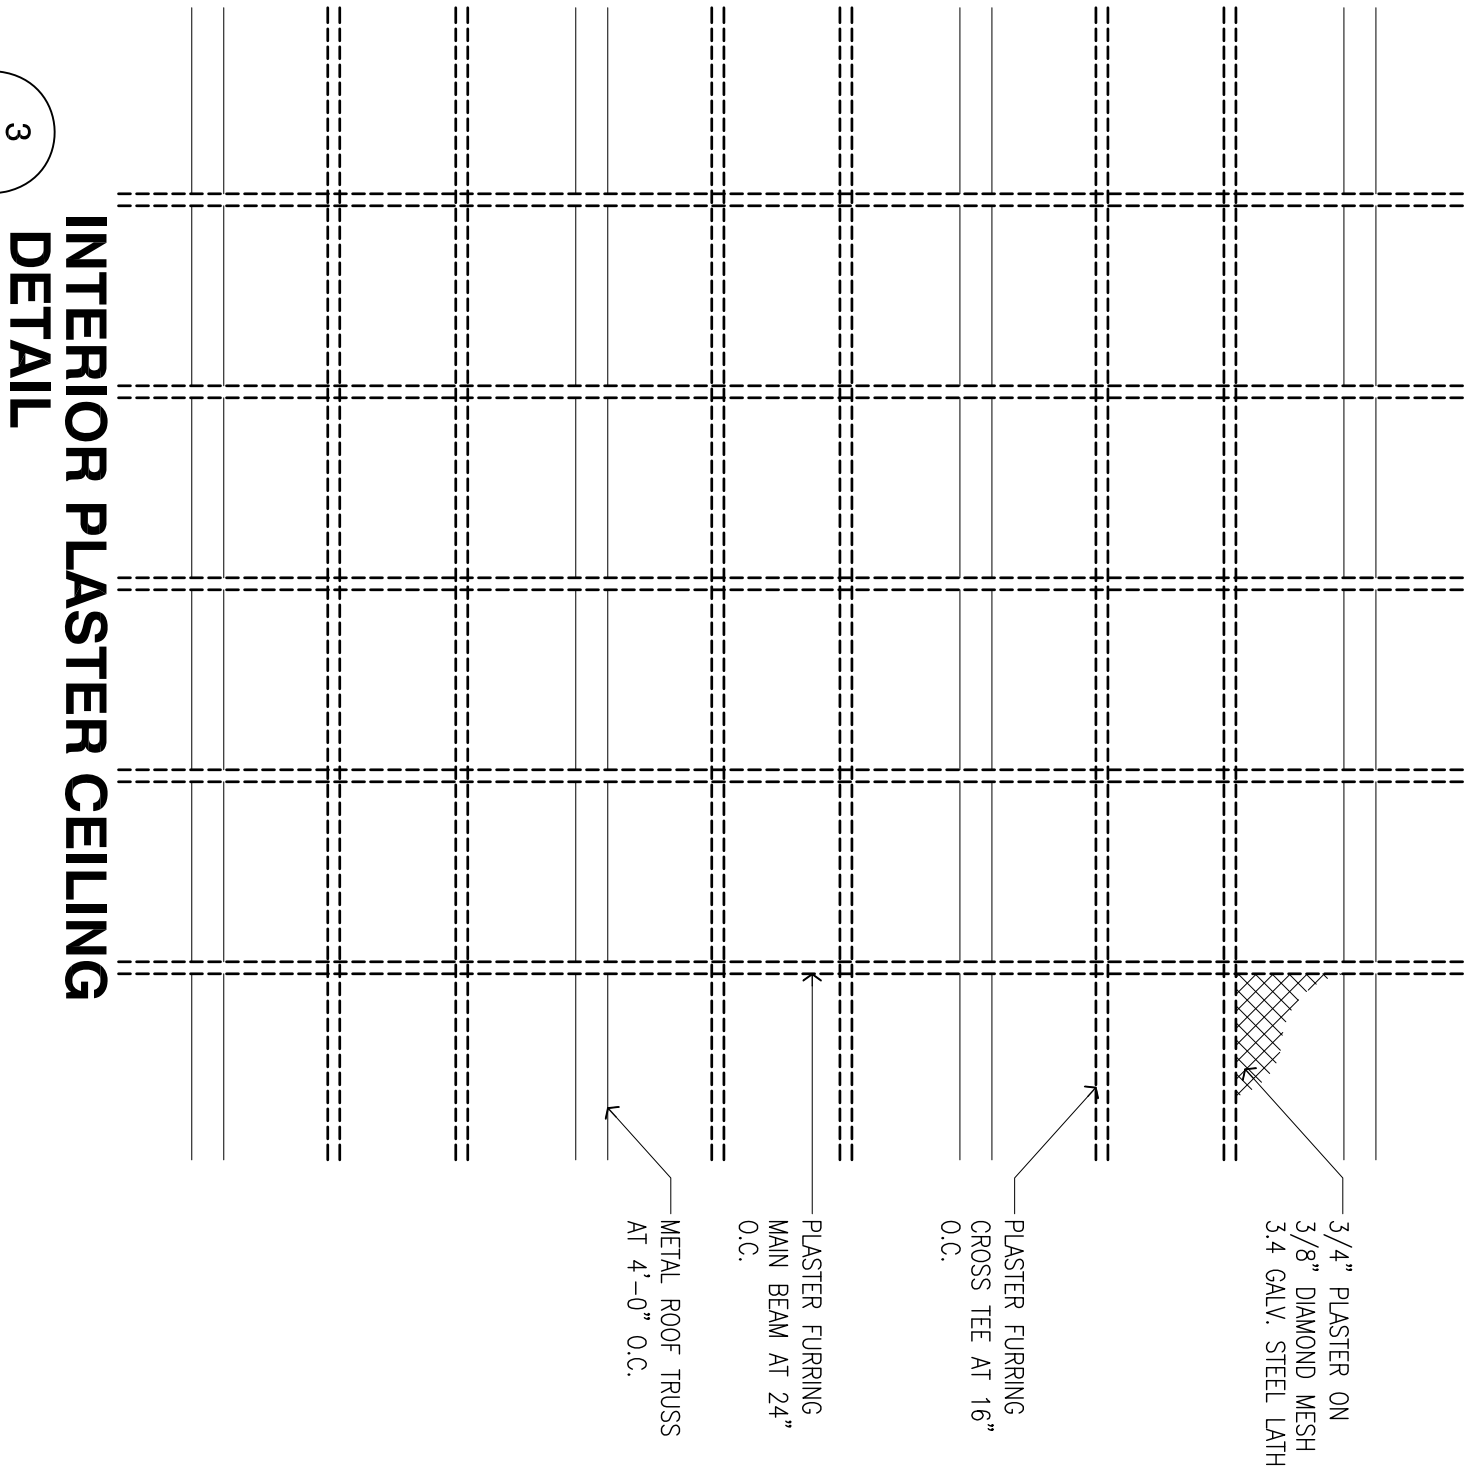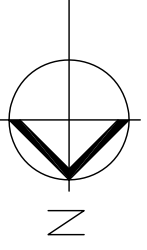


3 INTERIOR PLASTER CEILING
DETAIL
SCALE: 1/2" = 1'-0"

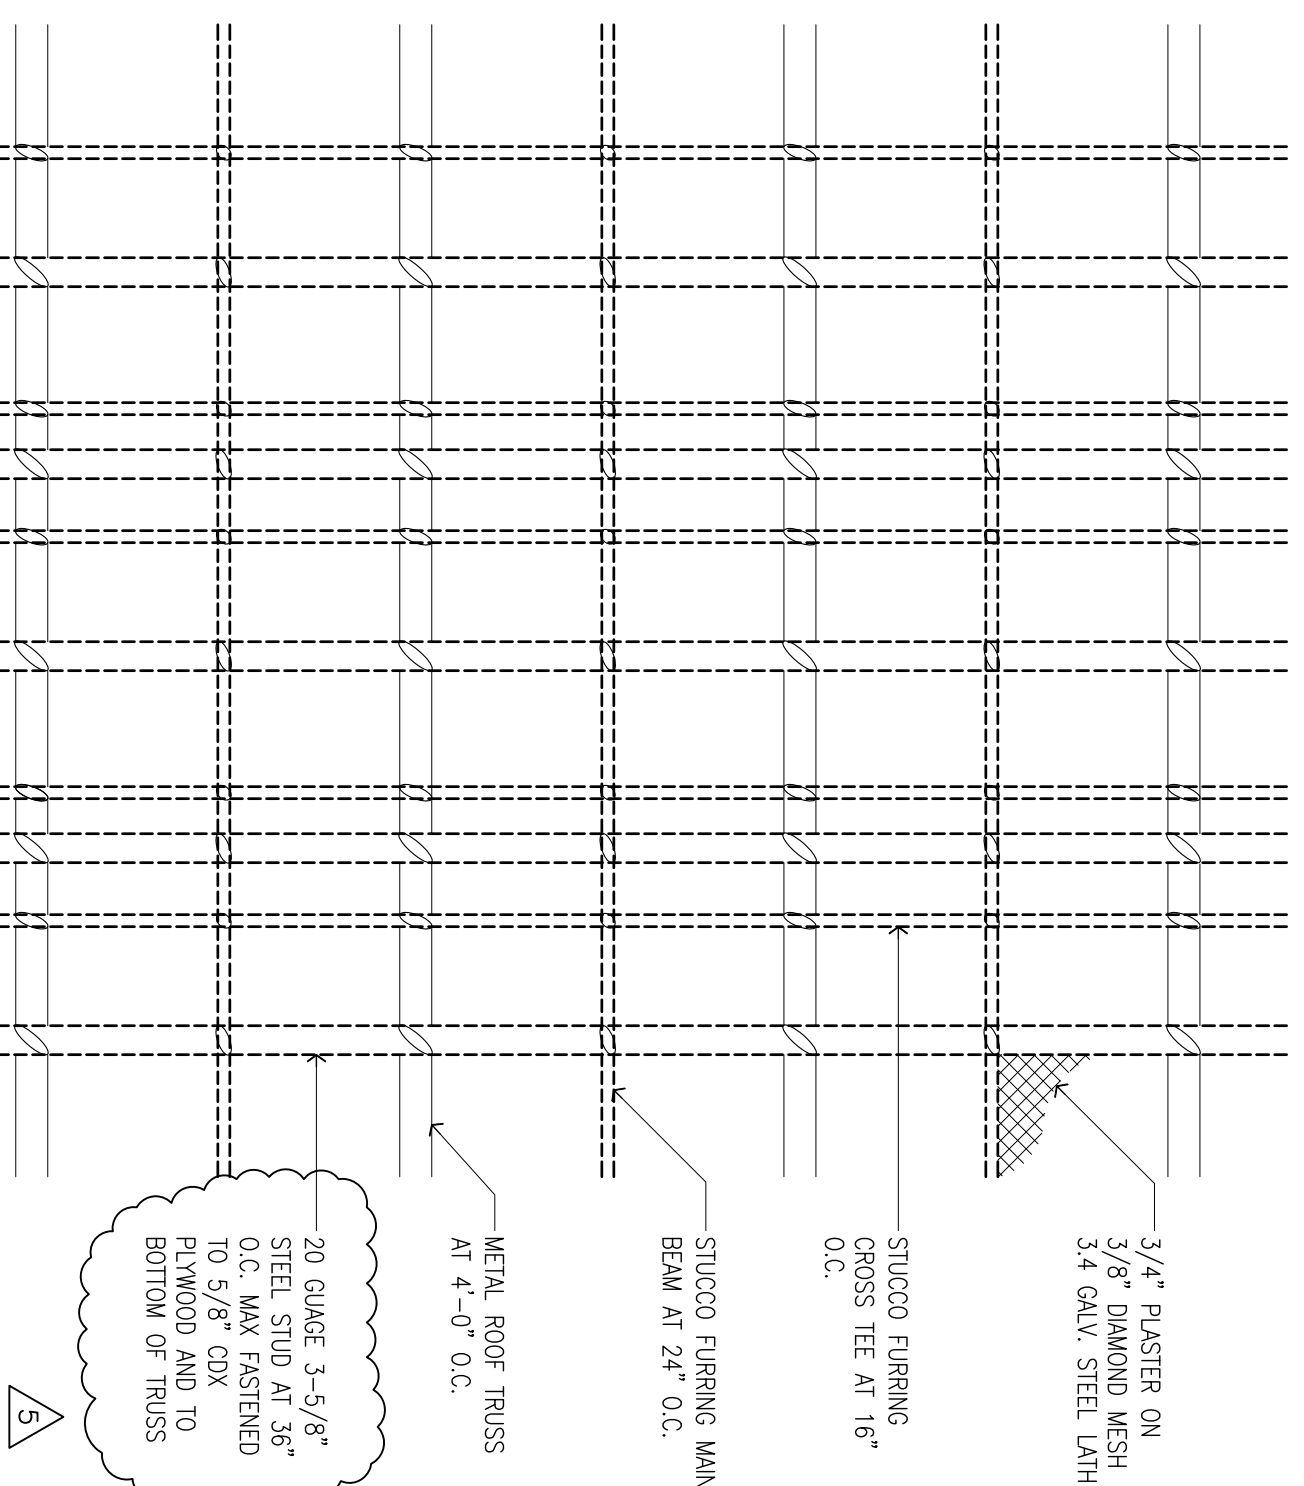

2 EXTERIOR STUCCO CEILING
DETAIL
SCALE: 1/16" = 1'-0"

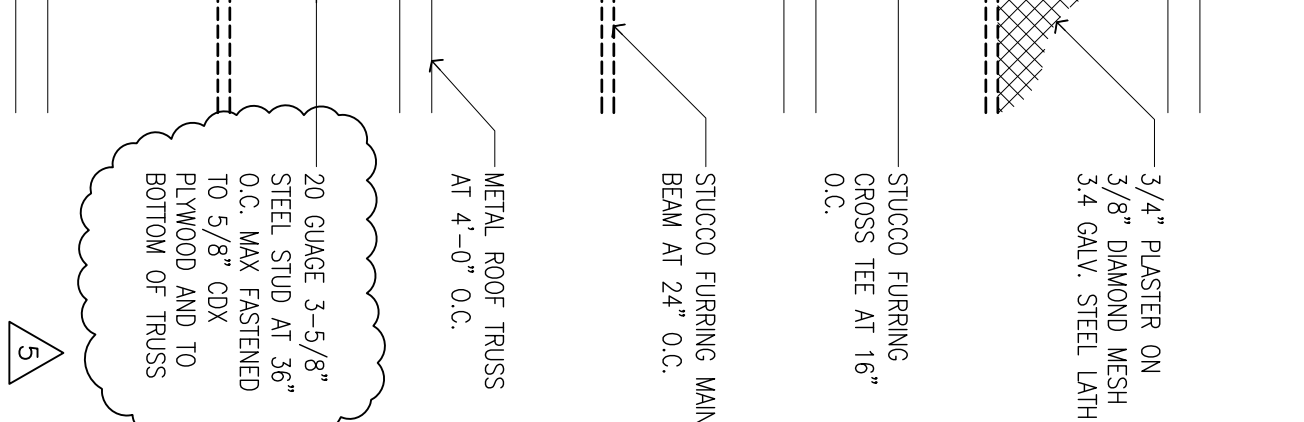

1 REFLECTED CEILING PLAN
SCALE: 1/8" = 1'-0"

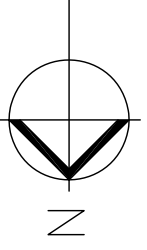

REFLECTED CEILING PLAN

SHEET INFORMATION:

JOB NO.:	011524.01	DATE ISSUED:	05/22/09
FILE NAME:		SHEET NUMBER:	A102
DRAWN BY:	E.D.		
CHECKED BY:	S.L.		
CC REVIEW:	C.A.		

SHEET ISSUE:

2	03/03/08	AS PER OWNERS COMMENTS
5	8/12/09	ADDENDUM

MARK DATE DESCRIPTION

PROFESSIONAL SEAL:
ARCHITECT OF RECORD:
CRISTINA FANDINO
REG. NO.: 00146922

NOT VALID FOR CONSTRUCTION
UNLESS SIGNED IN THIS BOX